




REVISIONS

NO.	DESCRIPTION	DATE

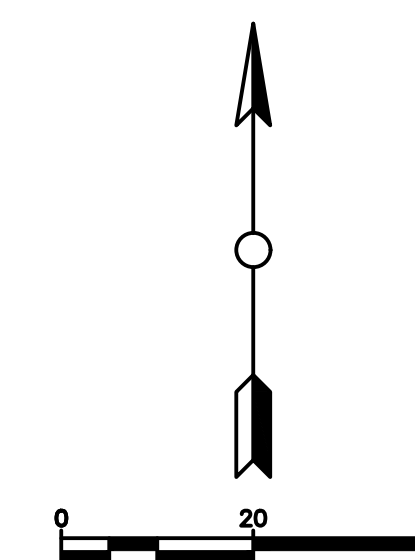

LEGEND

- WATER VALVE
- WATER METER
- POWER POLE
- OVERHEAD ELECTRIC
- FENCE

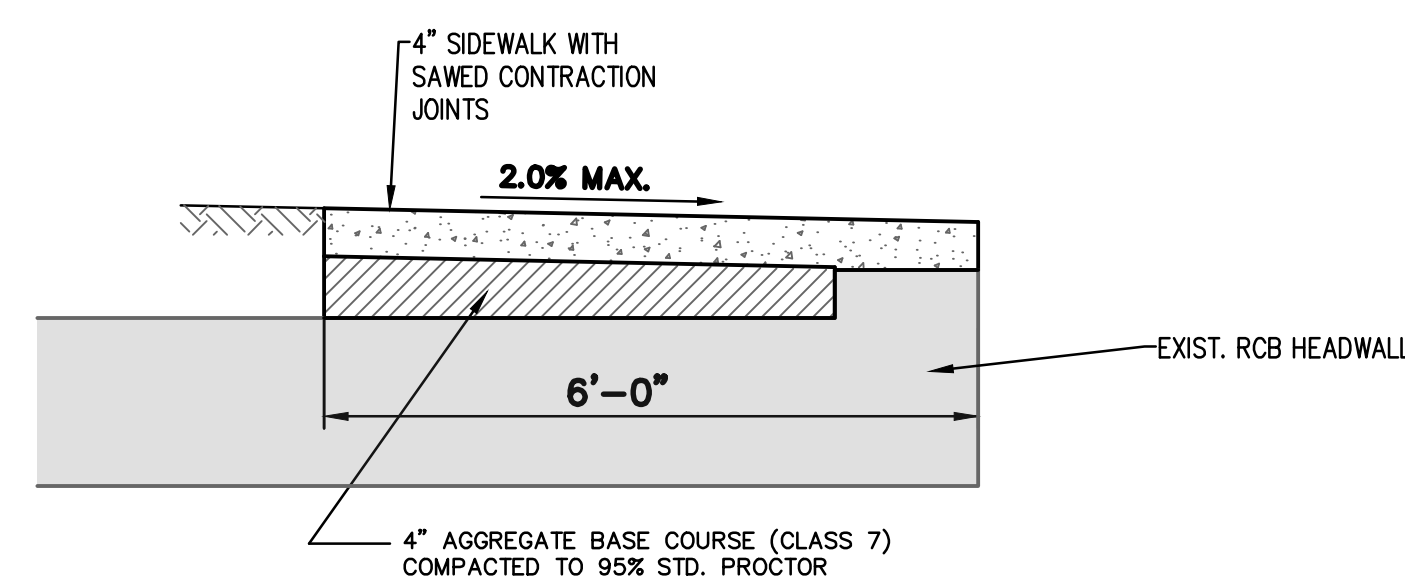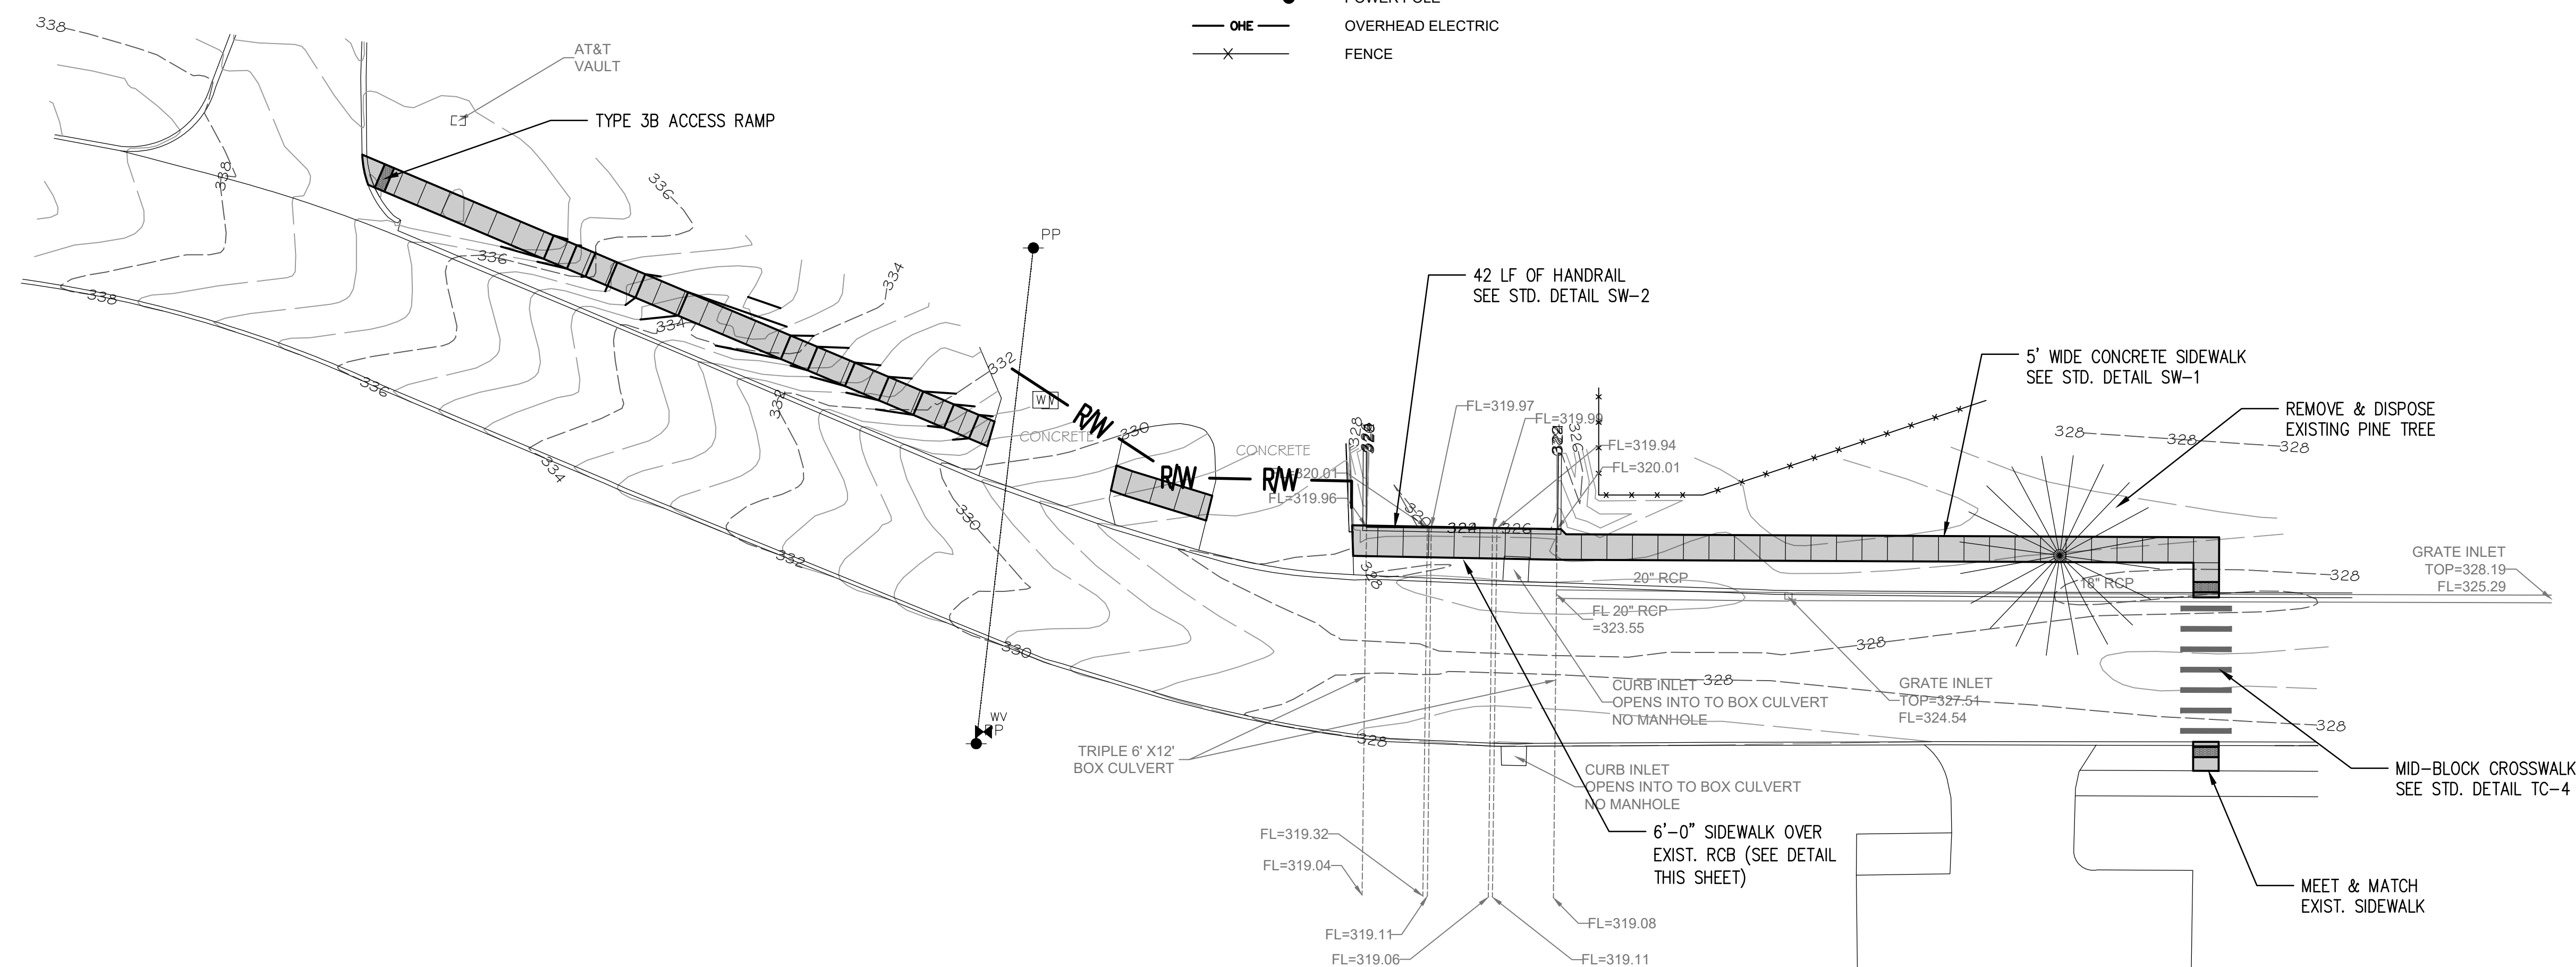

SIDEWALK SECTION AT RCB HEADWALL
 NTS

TYLER STREET SIDEWALK AT
 TUCKER CREEK
 CONWAY, ARKANSAS

JOB NUMBER: 20-117
 DRAWN BY: KJJ
 CHECKED BY: BFV3
 DATE: 9/13/19
 SCALE: 1"=20'

SITE PLAN

REVIEW PLANS
 NOT FOR CONSTRUCTION

C1